




PROJECT TITLE
TALUS
CORPORATE CENTER

OWNER
TALUS CORPORATE
CENTER, LLC

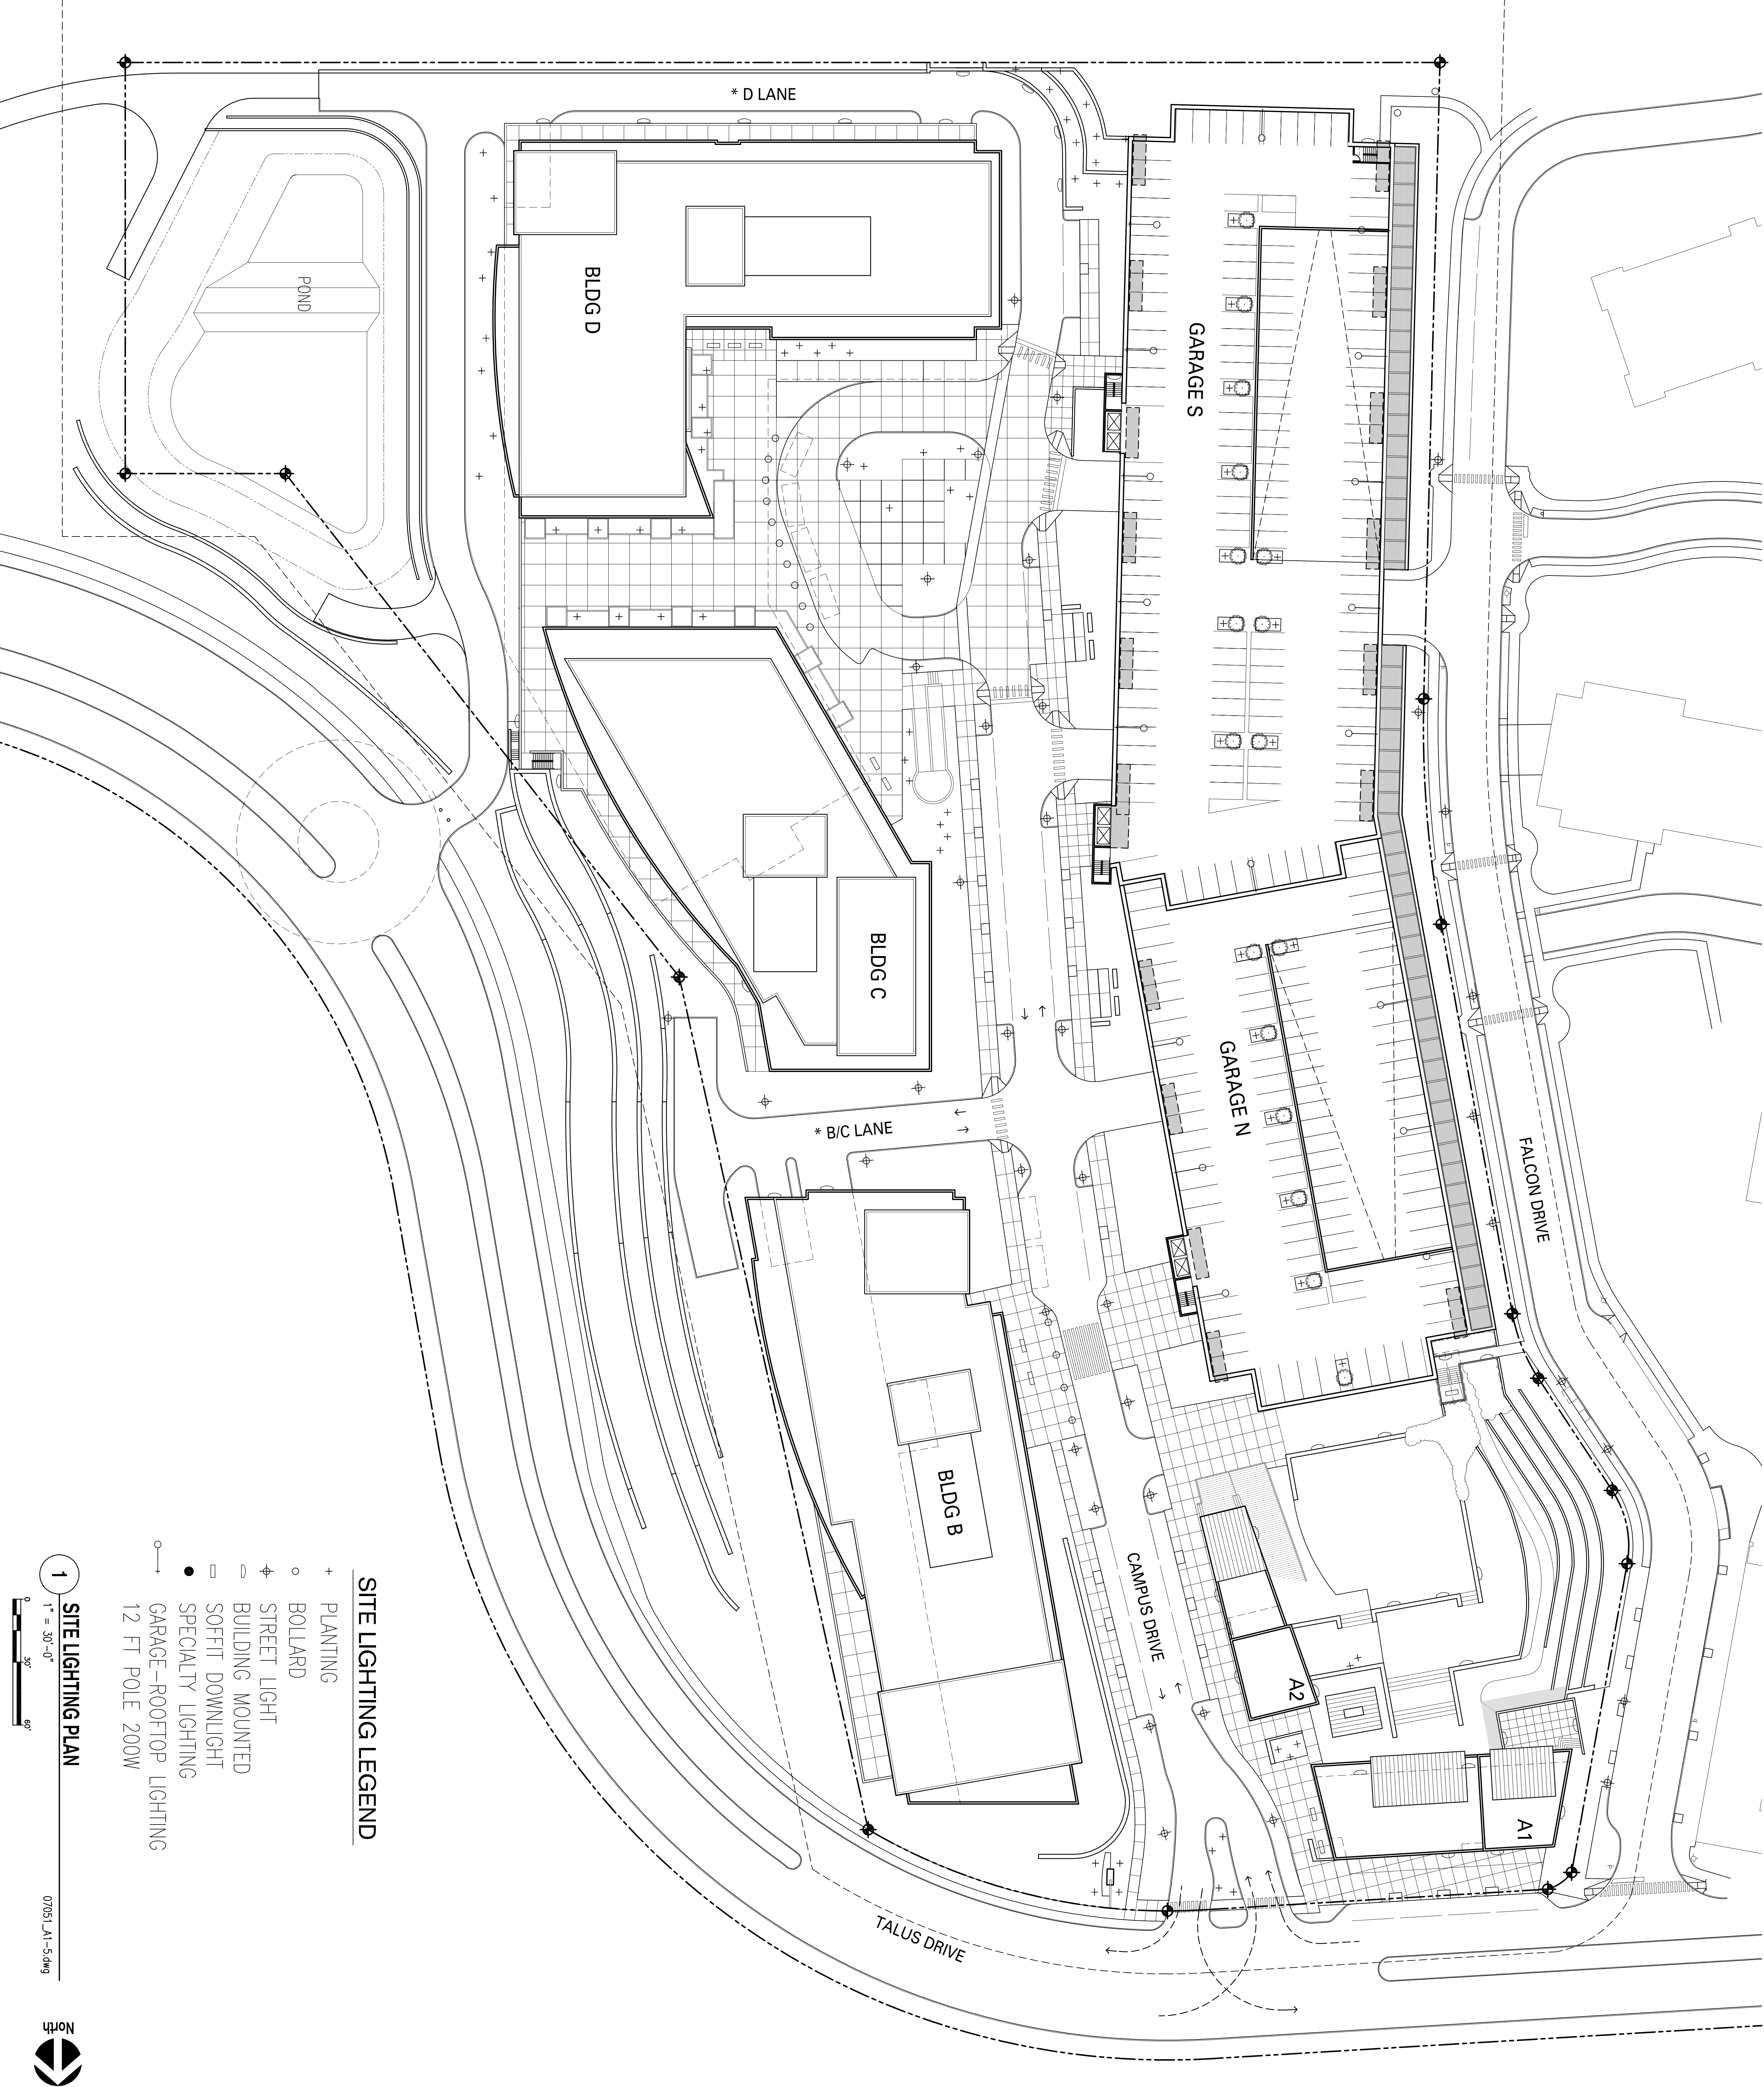

CONSULTANT

ISSUED:
MARK DATE DESCRIPTION

PROJECT NUMBER 07051
DRAWN BY BT
ISSUE DATE 10/24/07

STAMP

SHEET TITLE / NUMBER

SITE
LIGHTING PLAN

A1.5