



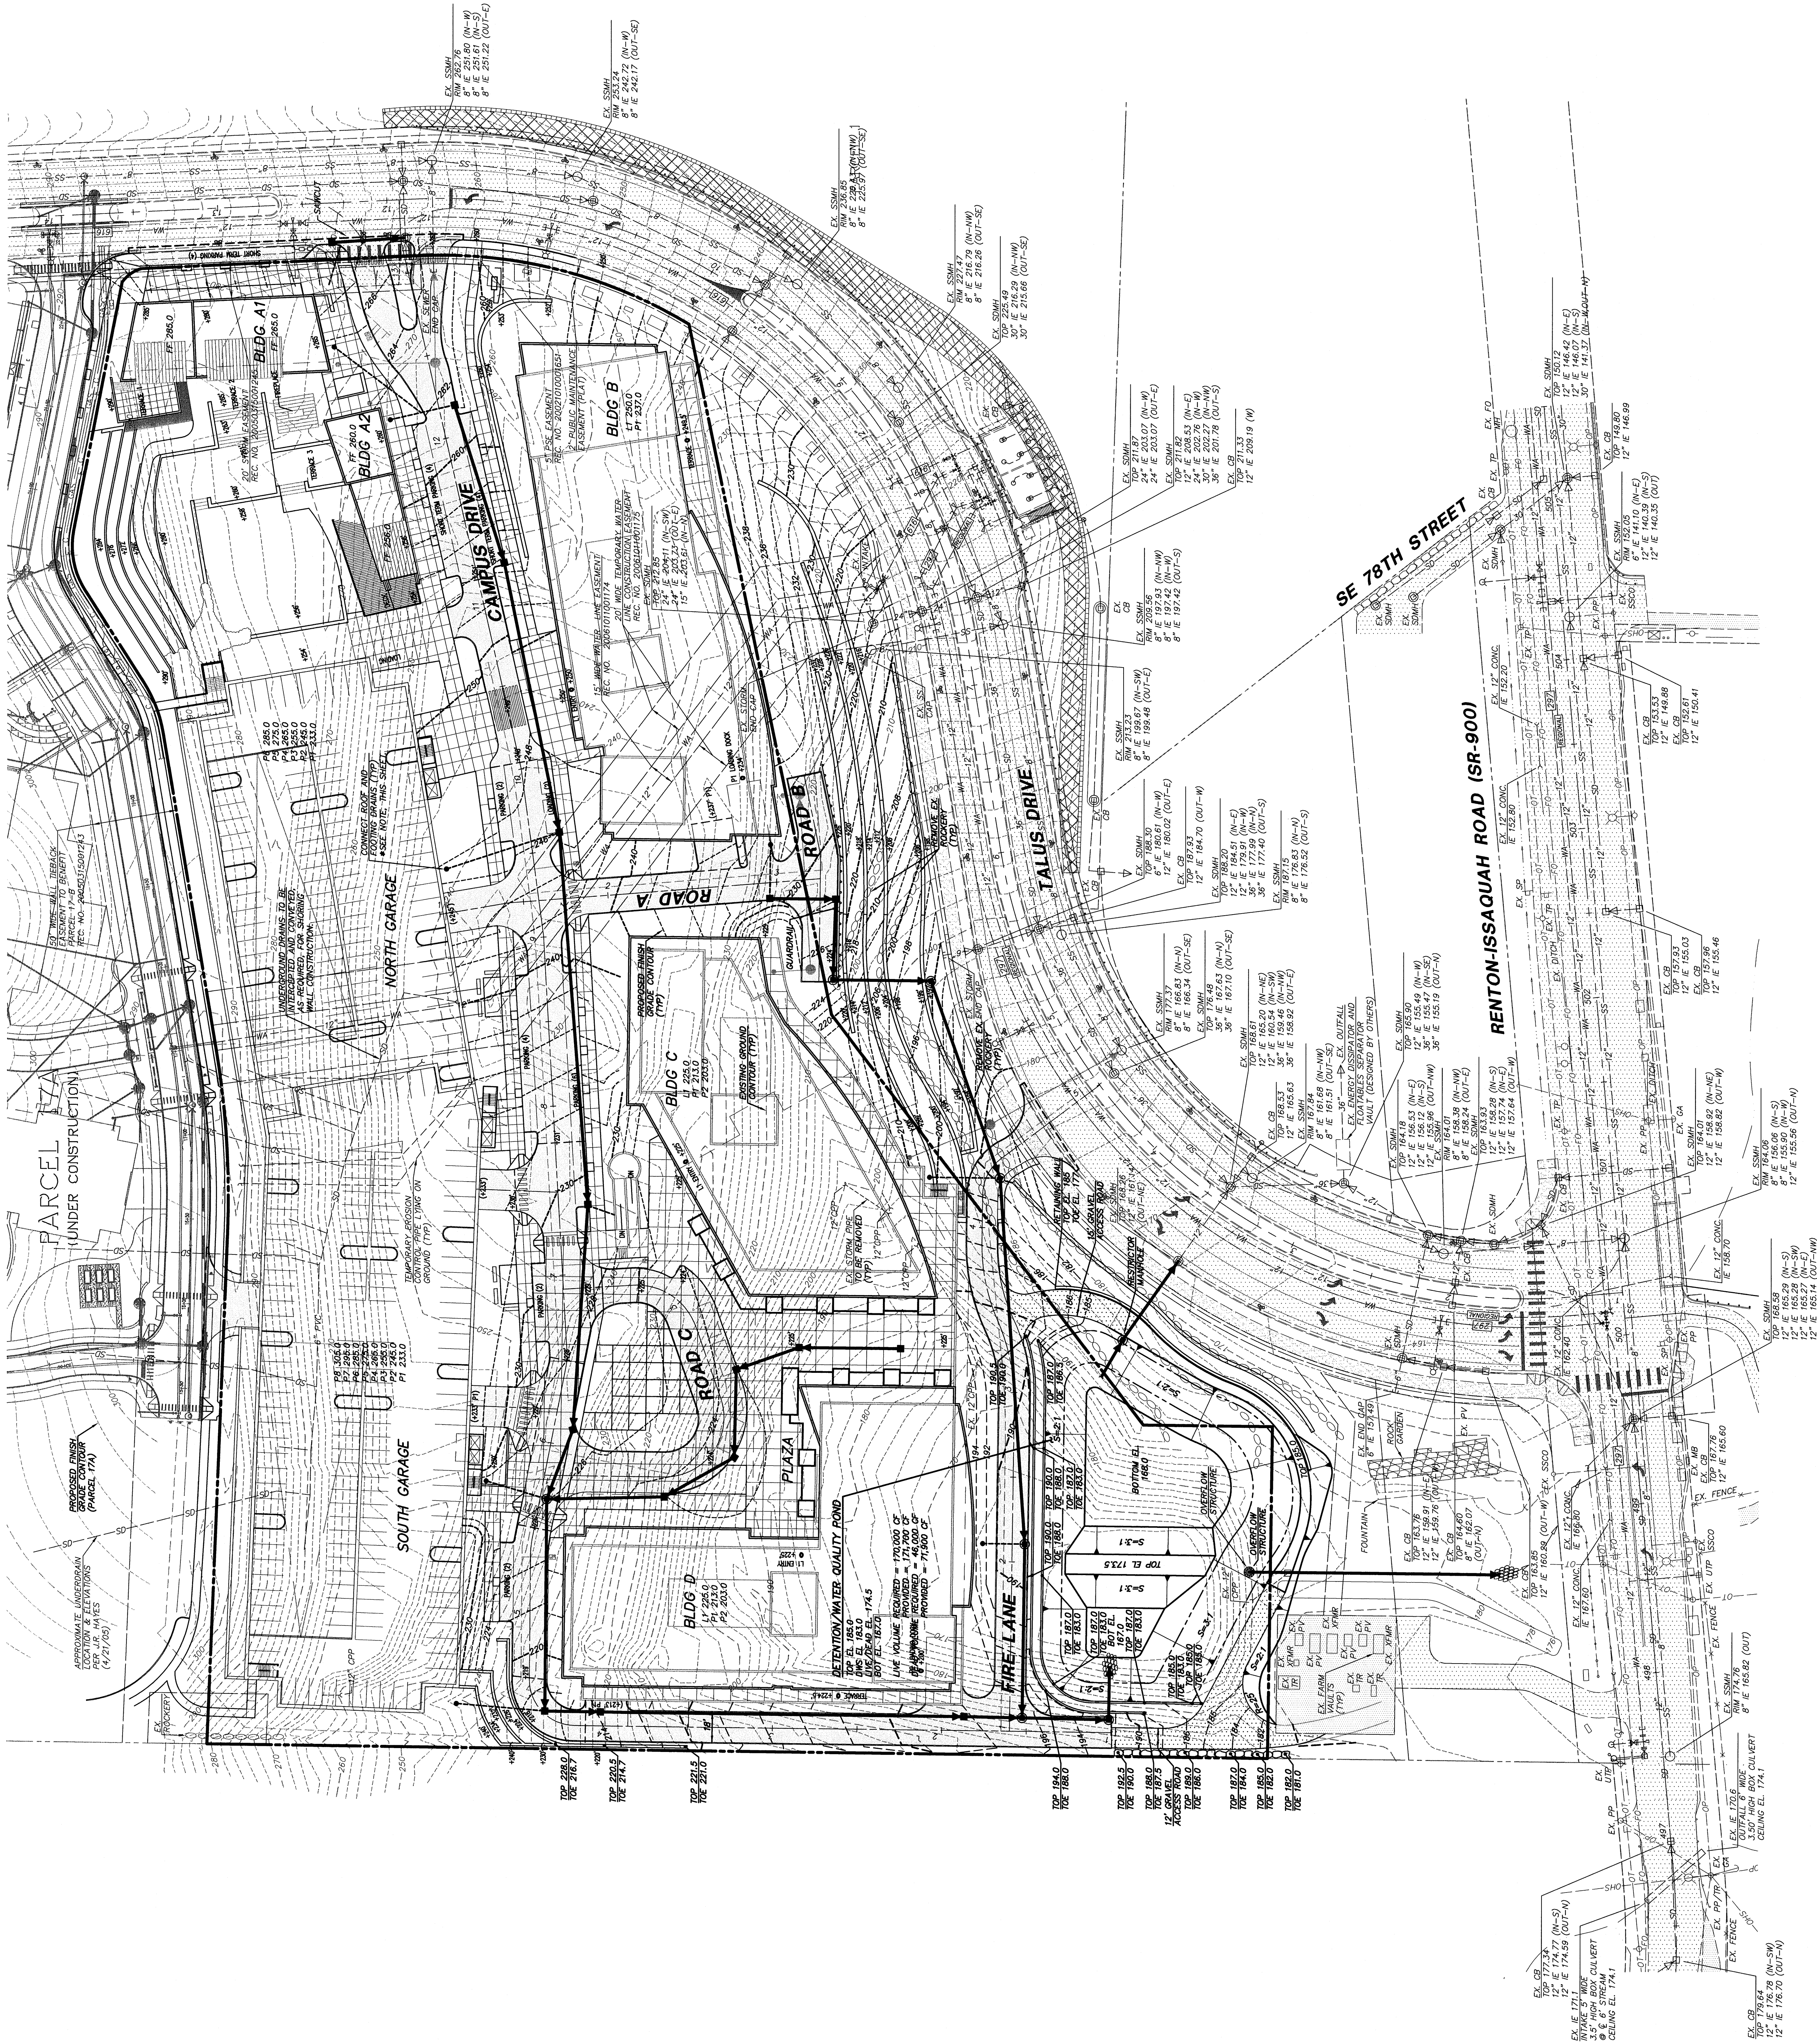

* NOTE: PARKING GARAGE FLOOR DRAINS SHALL BE DISCHARGED INTO GREASE INTERCEPTOR STRUCTURE PRIOR TO RELEASING TO SANITARY SEWER SYSTEM. SEE MECHANICAL PLANS.

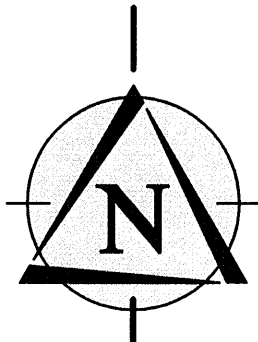


SCALE: 1" = 40'

LEGEND

————	BOUNDARY
————	CENTER LINE
————	EASEMENT
————	STORM DRAIN PIPE
————	ROOF & FOOTING DRAIN
————	EXISTING CONTOURS
————	2' EXISTING CONTOURS
————	10' PROPOSED CONTOURS
————	20' PROPOSED CONTOURS
————	422' RETAINING WALL
■	CATCH BASIN, TYPE I
●	CATCH BASIN, TYPE II
●	STORM CLEAFOUT

[illegible]

ONLY SHEETS WITH AUTHORIZING SIGNATURES
HAVE BEEN APPROVED FOR CONSTRUCTION

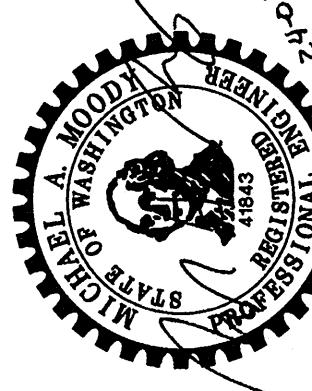

EXPIRES: 3/19/08

**STAMP NOT VALID
UNLESS SIGNED AND DATED**

06-170

C3 or C4

SECRET NO.